




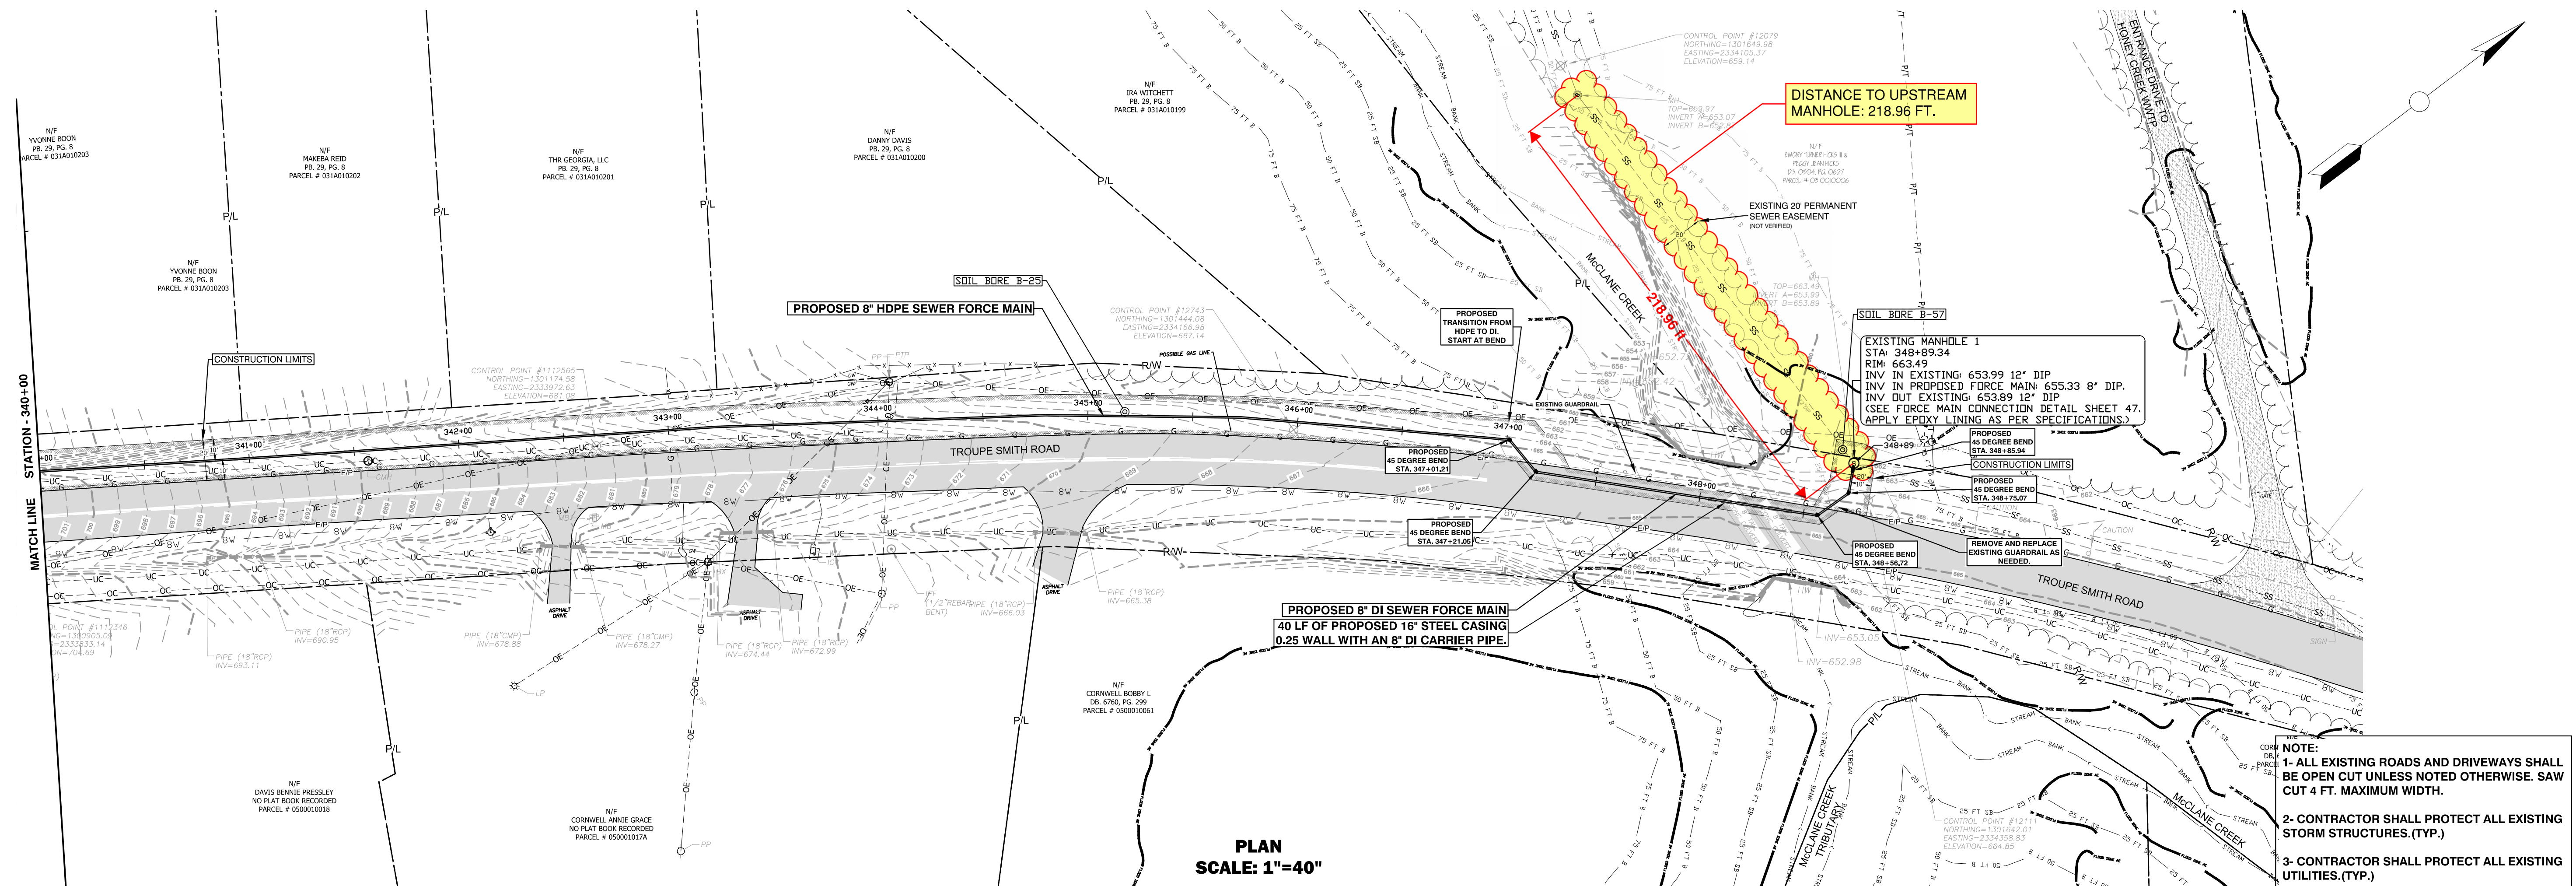


PROFILE
SCALE HORIZONTAL: 1"=40'
SCALE VERTICAL: 1"=10'

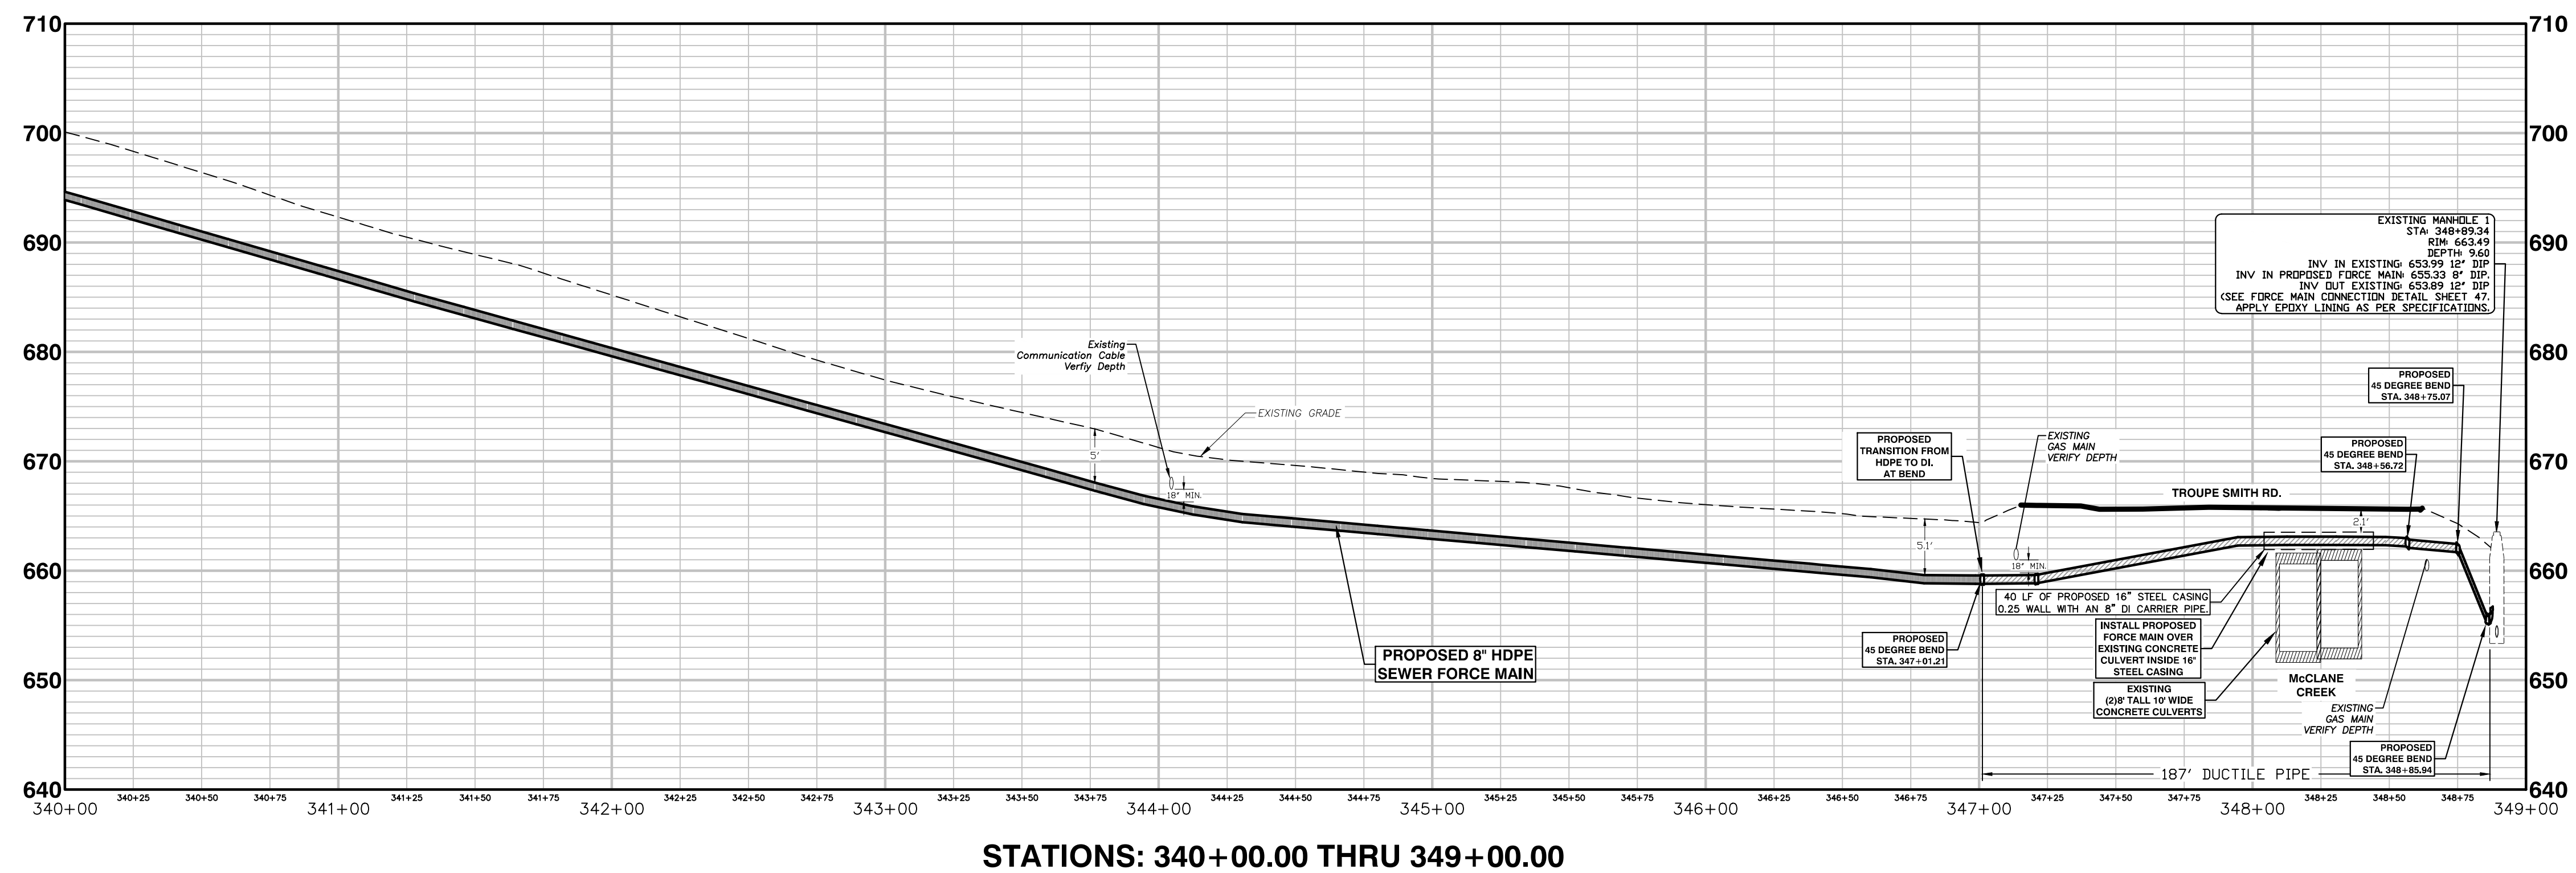

No.	DATE	DESCRIPTION	No.	DATE	DESCRIPTION
4	7/15/2025	COUNTY REVIEW COMMENTS	—	—/—/—	—
6	1/6/2026	FOR BIDDING ONLY	—	—/—/—	—
—	—/—/—	—	—	—/—/—	—
—	—/—/—	—	—	—/—/—	—
—	—/—/—	—	—	—/—/—	—
—	—/—/—	—	—	—/—/—	—

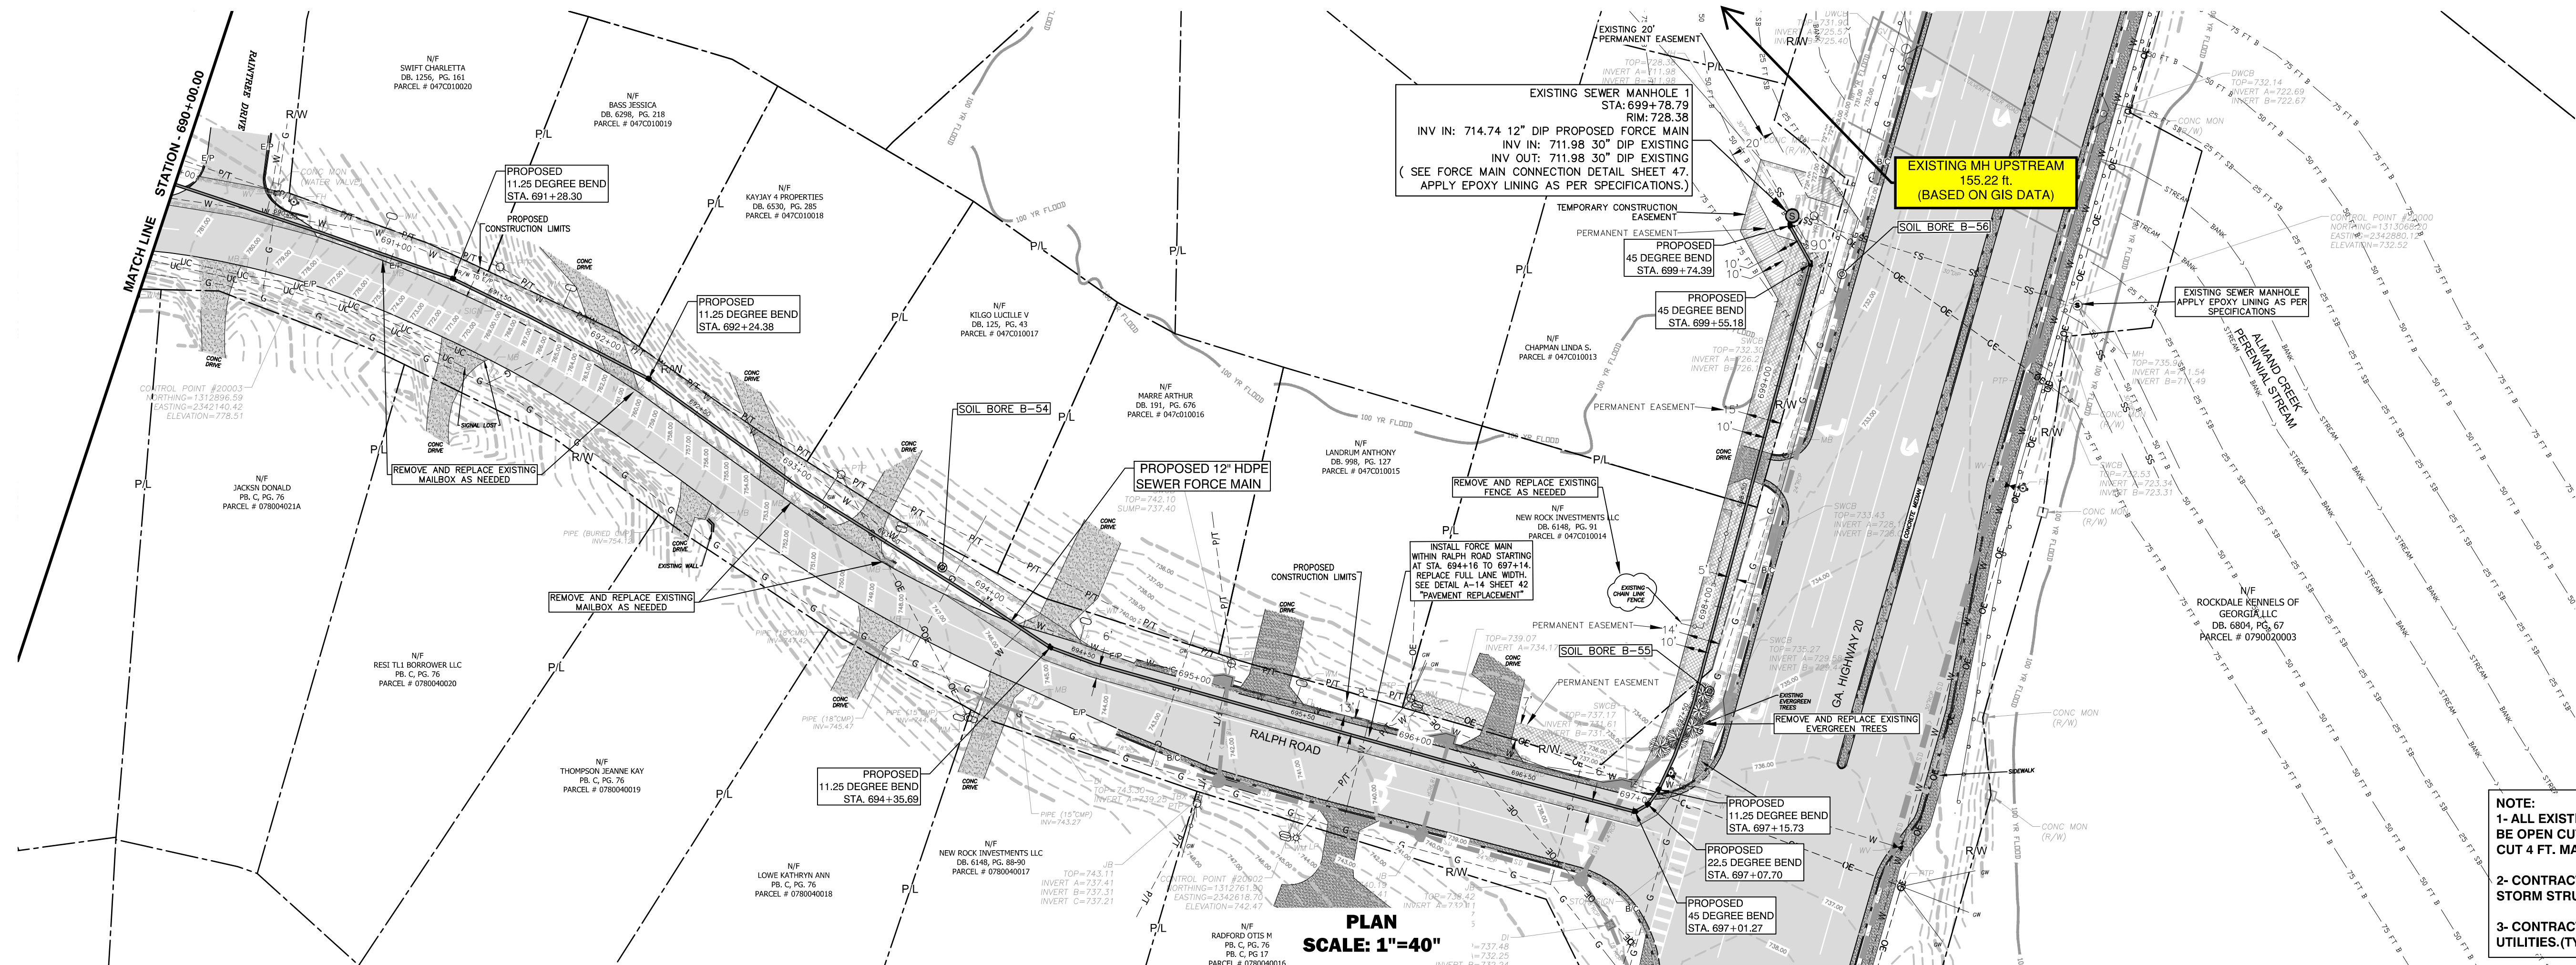

PLAN
SCALE: 1"=40"

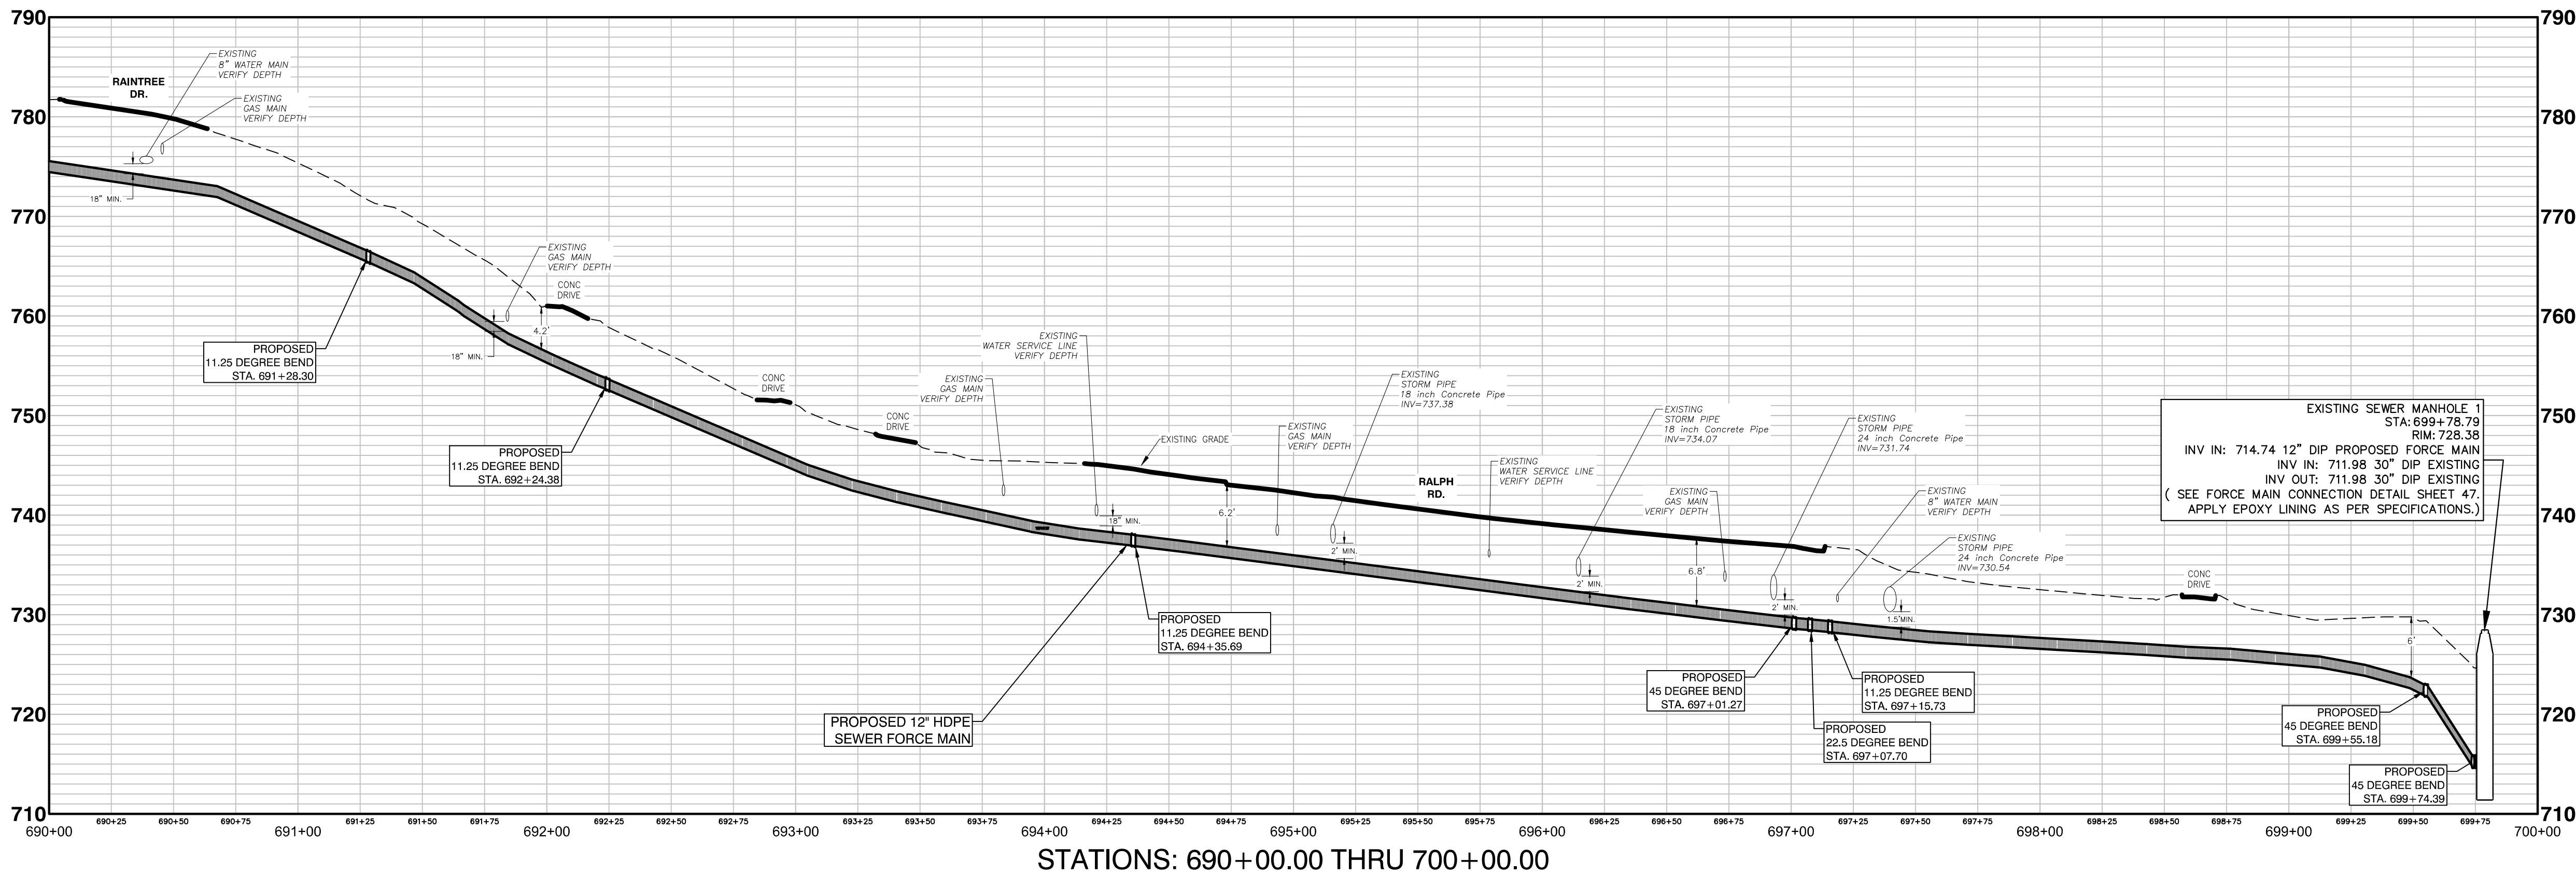

PROFILE
SCALE HORIZONTAL: 1"=40"
SCALE VERTICAL: 1"=10'



ROCKDALE WATER RESOURCES



GEORGIA 811
Utilities Protection Council, Inc.
Know what's below.
Call before you dig.

REVISION	
No.	DESCRIPTION
1	1/23/2024 COUNTY REVIEW COMMENTS
2	1/23/2024 COUNTY REVIEW COMMENTS
3	1/23/2024 COUNTY REVIEW COMMENTS
4	1/23/2024 COUNTY REVIEW COMMENTS
5	1/23/2024 COUNTY REVIEW COMMENTS
6	1/23/2024 COUNTY REVIEW COMMENTS

DESIGNED BY: DAVID CERVONE



DRAWN BY: WALT BOBO


CHECKED BY: DAVID CERVONE

DATE: 09/01/2025

FILE NAME: HONEY CREEK & SOUTH CREEK
DIP-30-01-01-01

SHEET	DRAWING No.
39	C-35

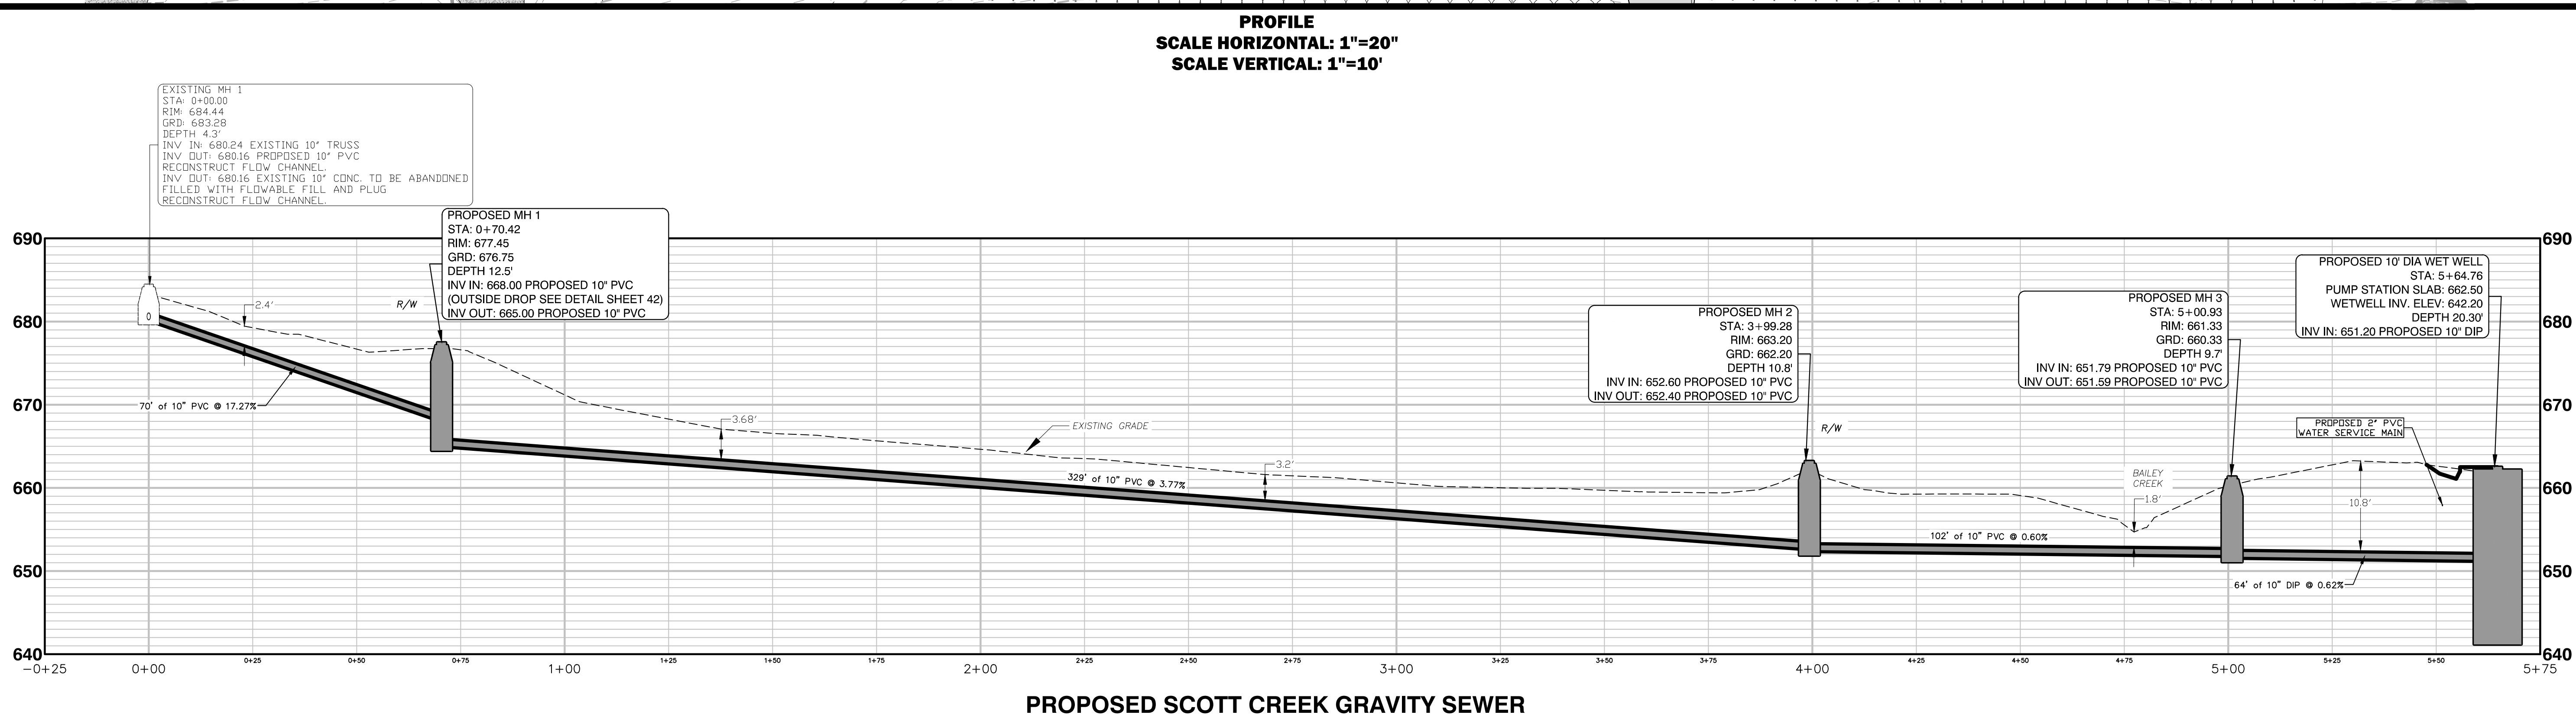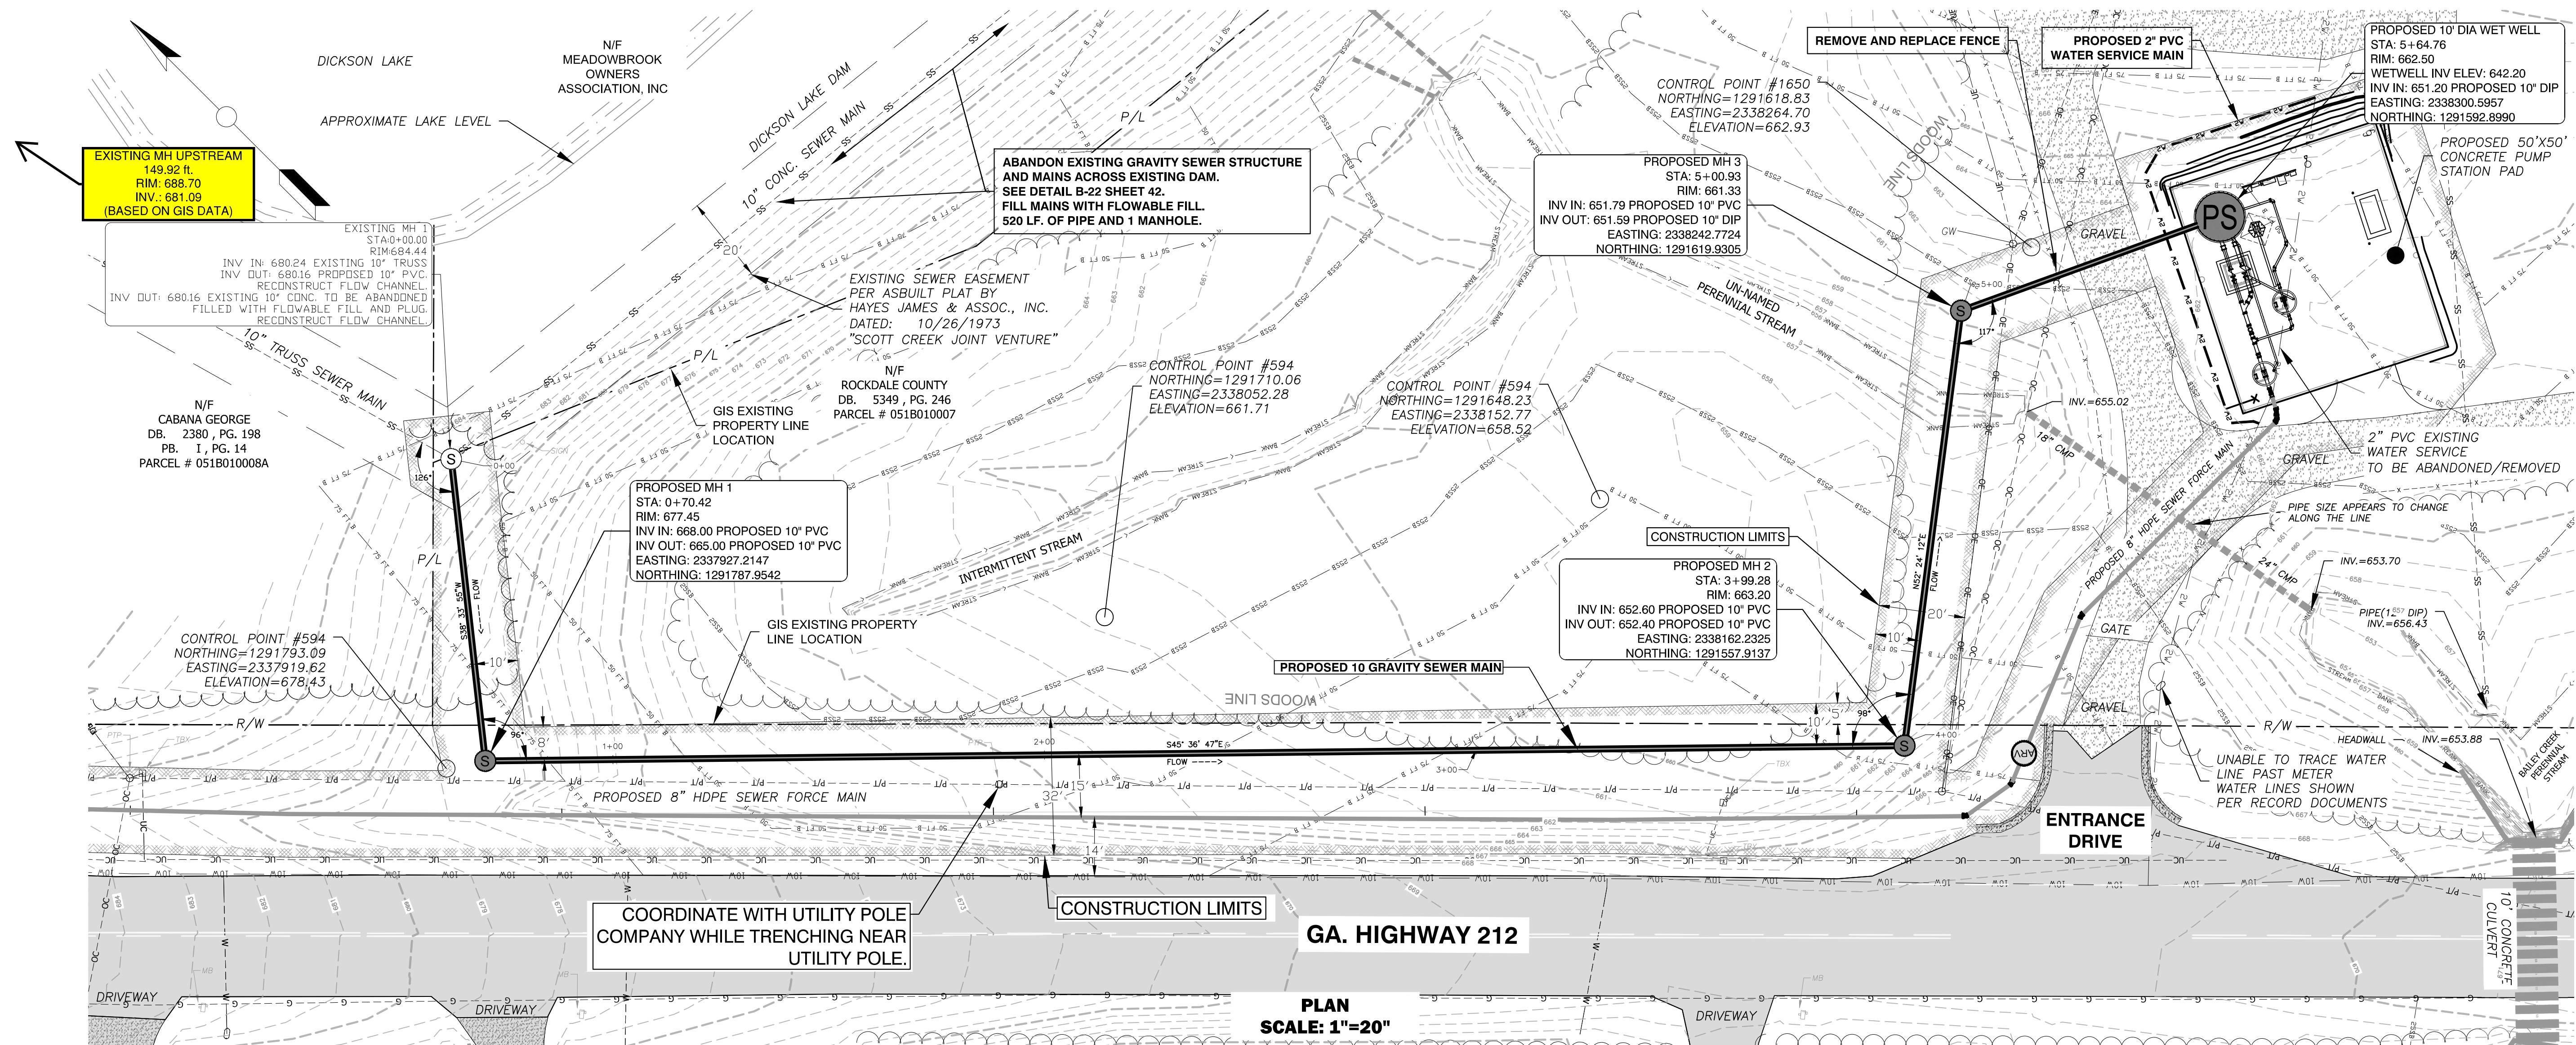

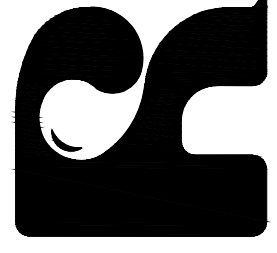

ROCKDALE WATER RESOURCES



Georgia 811
Utilities Protection Center, Inc.
Call before you dig.

REVISION	
No.	DESCRIPTION
1	1/23/2024 COUNTY REVIEW COMMENTS
2	1/23/2024 COUNTY REVIEW COMMENTS
3	1/23/2024 COUNTY REVIEW COMMENTS
4	1/23/2024 COUNTY REVIEW COMMENTS
5	1/23/2024 COUNTY REVIEW COMMENTS
6	1/23/2024 COUNTY REVIEW COMMENTS
7	1/23/2024 COUNTY REVIEW COMMENTS
8	1/23/2024 COUNTY REVIEW COMMENTS

DESIGNED BY: DAVID CERVONE

DRAWN BY: WALT BOBO

CHECKED BY: DAVID CERVONE

DATE: 09/01/2025


FILE NAME: HENRY CREEK & SCOTT CREEK PUMP STA & FM

SHEET


40

DRAWING No.


C-36

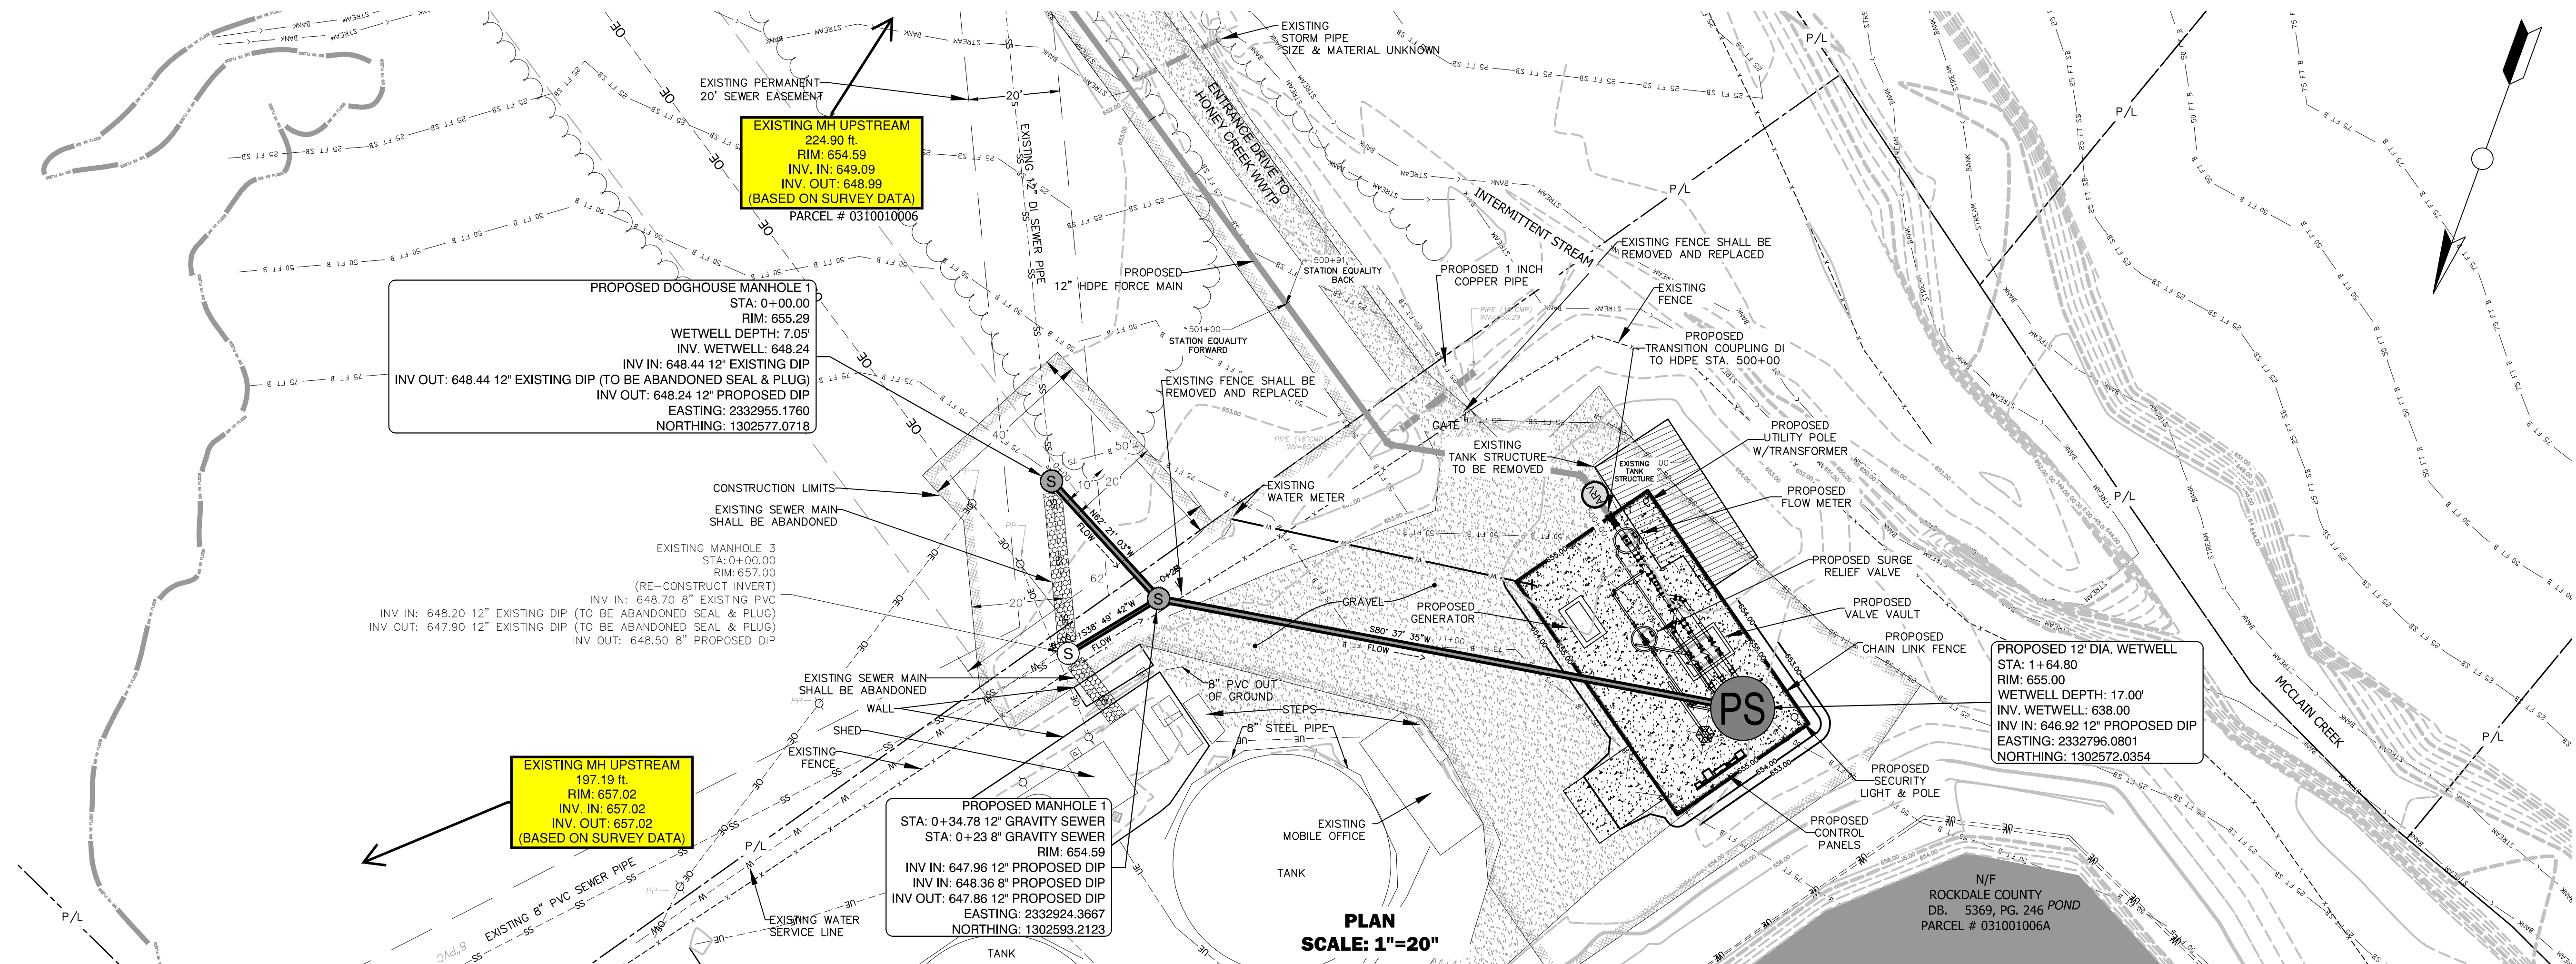

PROFILE
SCALE HORIZONTAL: 1"=20"
SCALE VERTICAL: 1"=10'

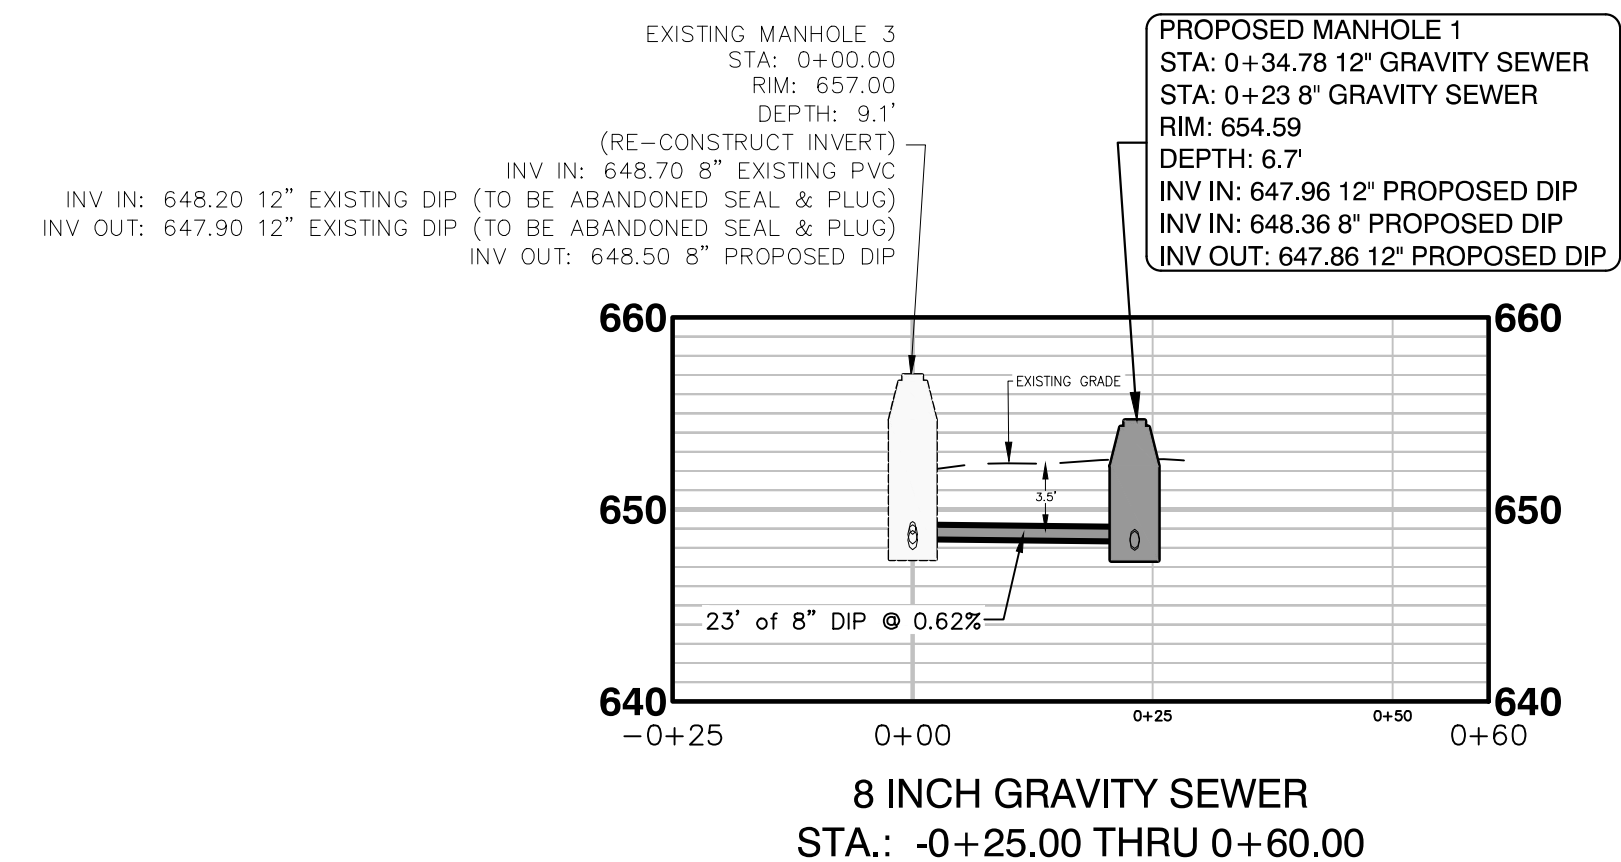

8 INCH GRAVITY SEWER
STA.: -0+25.00 THRU 0+60.00

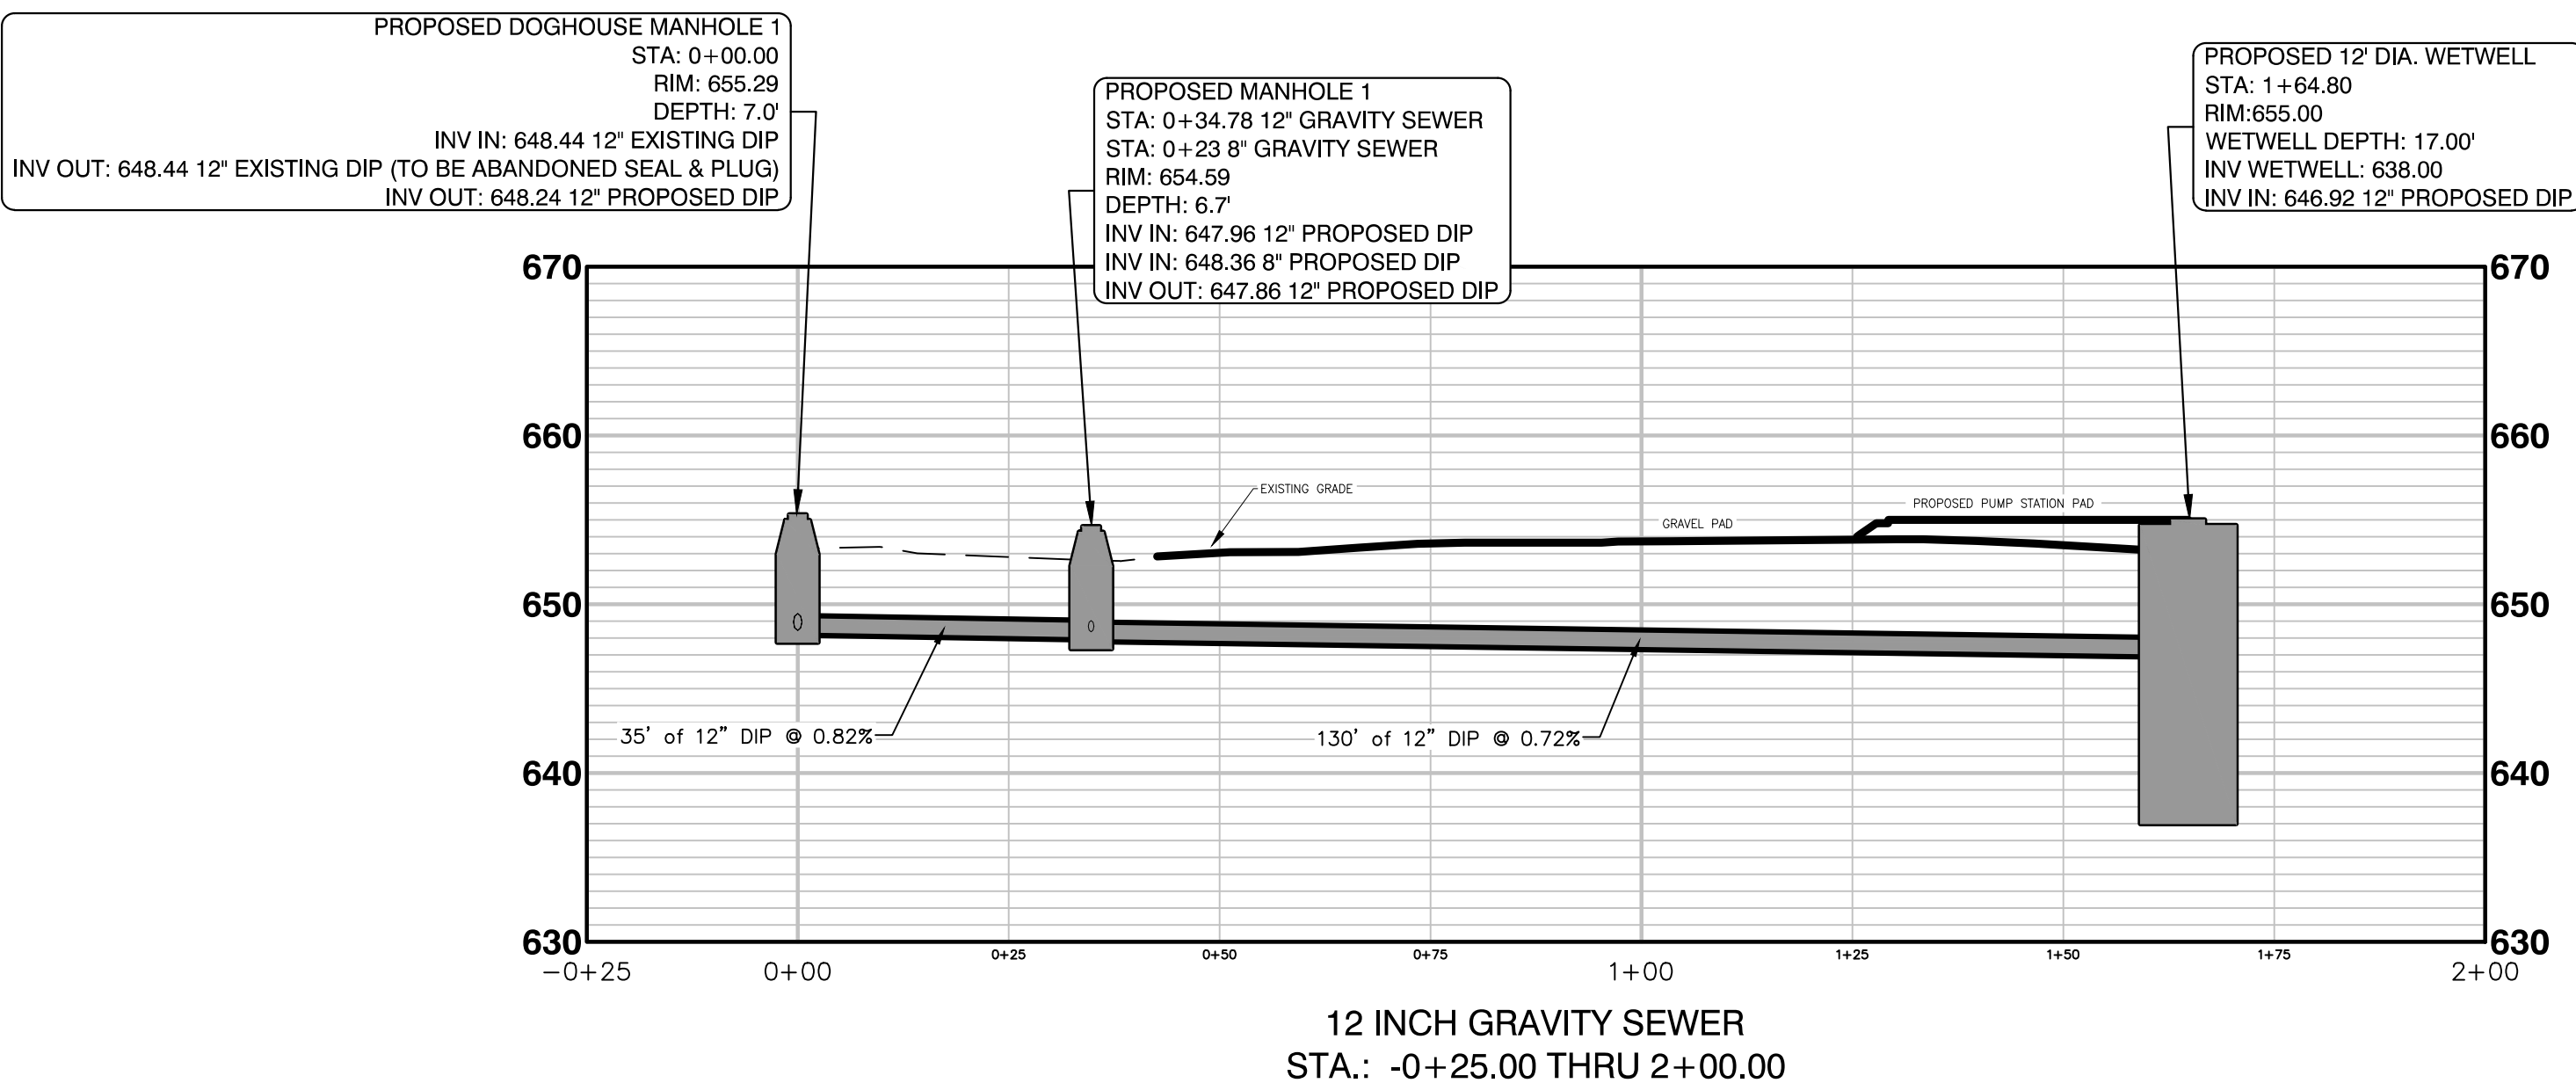

12 INCH GRAVITY SEWER
STA.: -0+25.00 THRU 2+00.00



REVISION		No.		DATE		DESCRIPTION	
1	1/23/2024	1	1/23/2024	1	1/23/2024	1	1/23/2024
2	7/15/2025	2	7/15/2025	2	7/15/2025	2	7/15/2025
3	7/15/2025	3	7/15/2025	3	7/15/2025	3	7/15/2025
4	7/15/2025	4	7/15/2025	4	7/15/2025	4	7/15/2025
5	7/15/2025	5	7/15/2025	5	7/15/2025	5	7/15/2025
6	7/15/2025	6	7/15/2025	6	7/15/2025	6	7/15/2025
7	7/15/2025	7	7/15/2025	7	7/15/2025	7	7/15/2025
8	7/15/2025	8	7/15/2025	8	7/15/2025	8	7/15/2025
9	7/15/2025	9	7/15/2025	9	7/15/2025	9	7/15/2025
10	7/15/2025	10	7/15/2025	10	7/15/2025	10	7/15/2025

PLAN AND PROFILE
HONEY CREEK GRAVITY SEWER

DESIGNED BY: DAVID CERVONE
DRAWN BY: WALT BOBO
CHECKED BY: DAVID CERVONE
DATE: 09/01/2025
FILE NAME: HONEY CREEK & SCOTT CREEK
PUMP STATION JUNE